



Ground Floor Plan

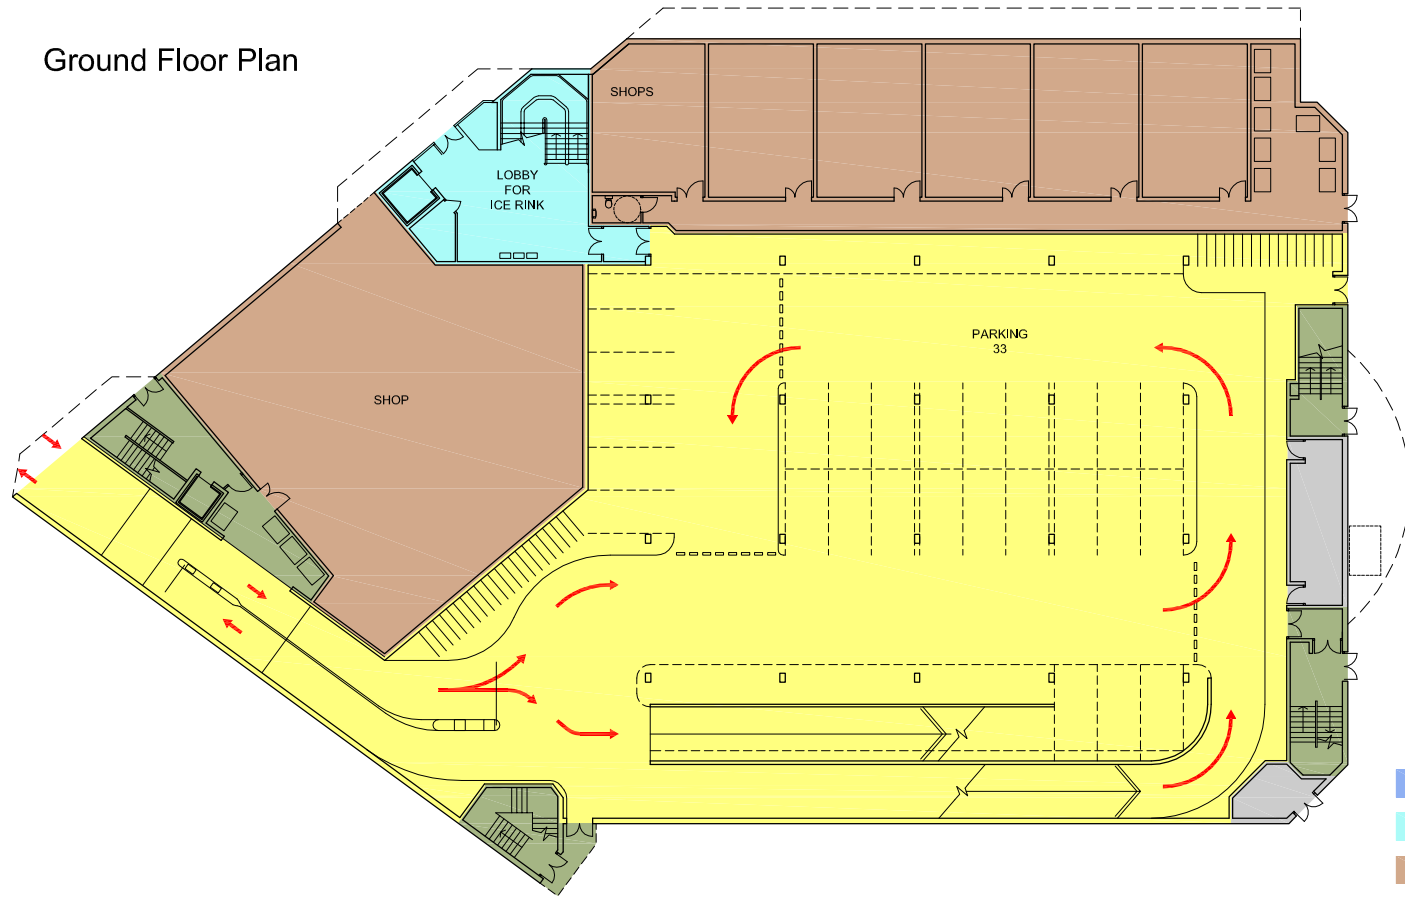


First Floor Plan

 
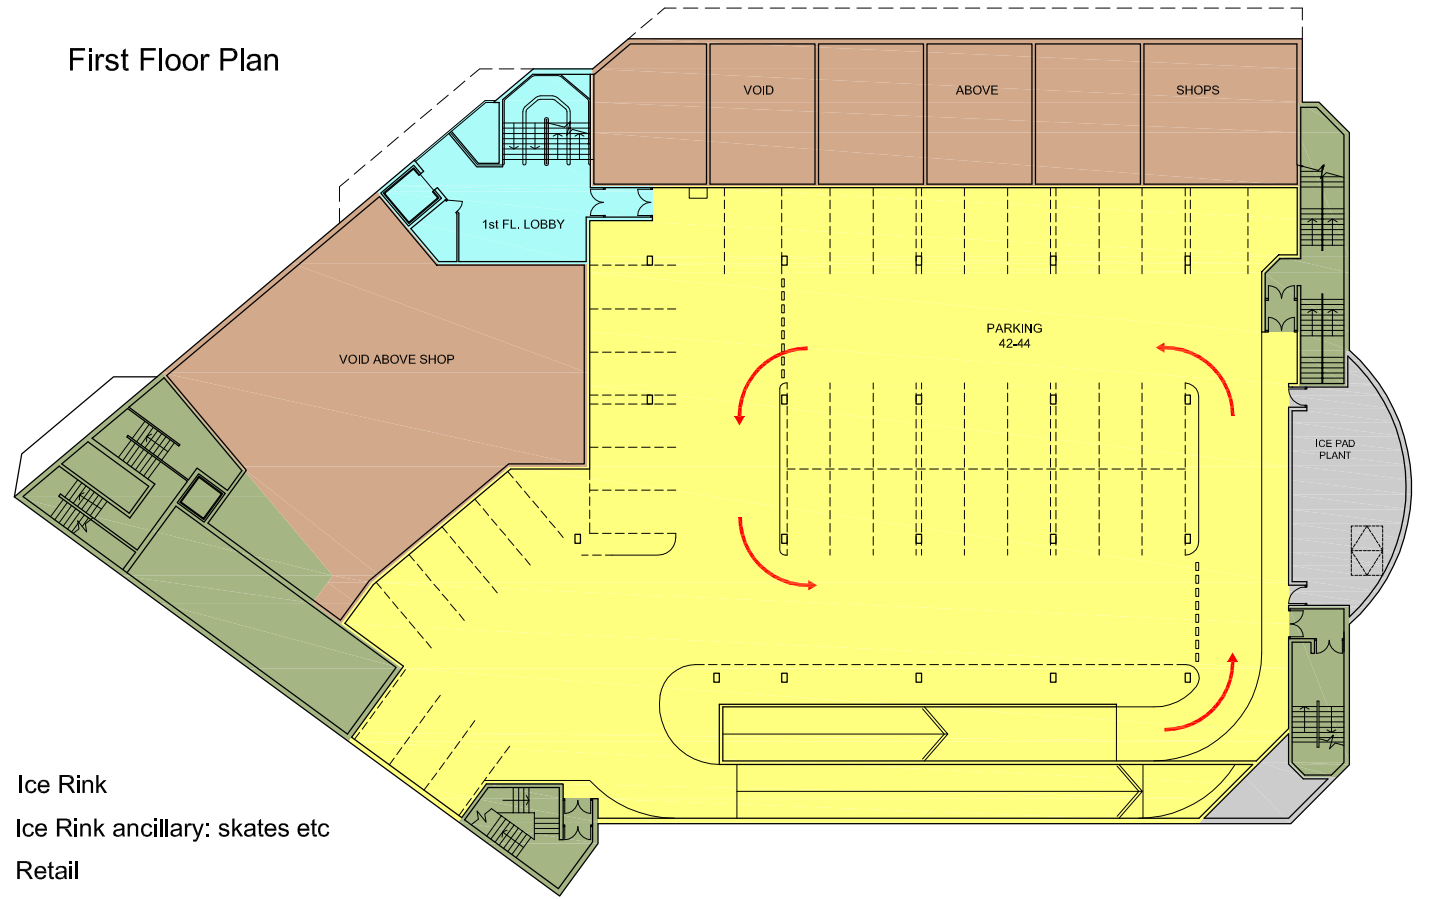


- Ice Rink
- Ice Rink ancillary: skates etc
- Retail
- Gymnasium
- Restaurant and Cafe
- Parking
- Stairs and Means of Escape
- Mechanical Plant

Second Floor Plan

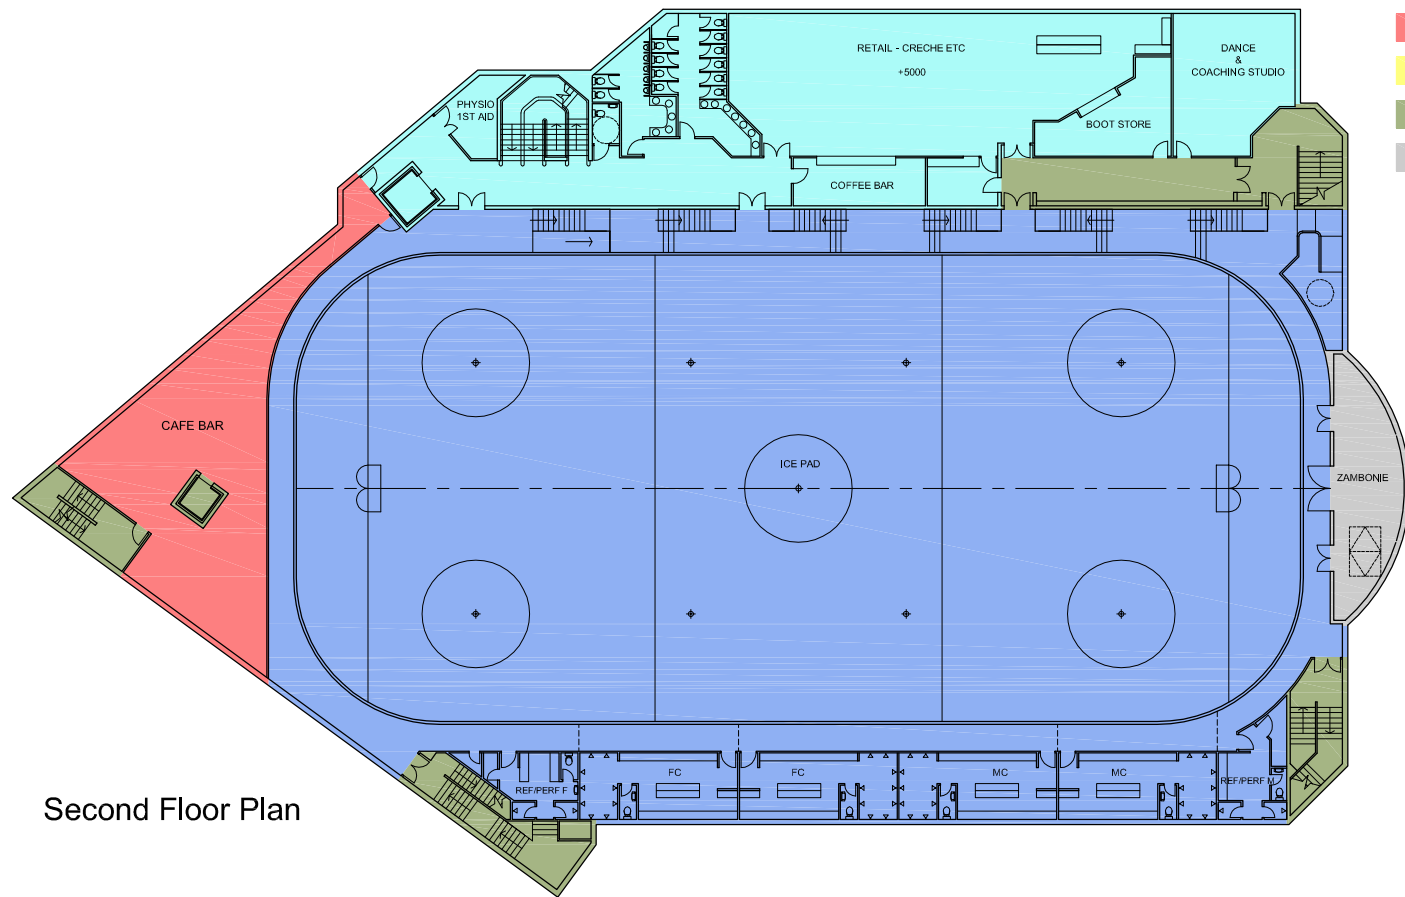

Third Floor Plan

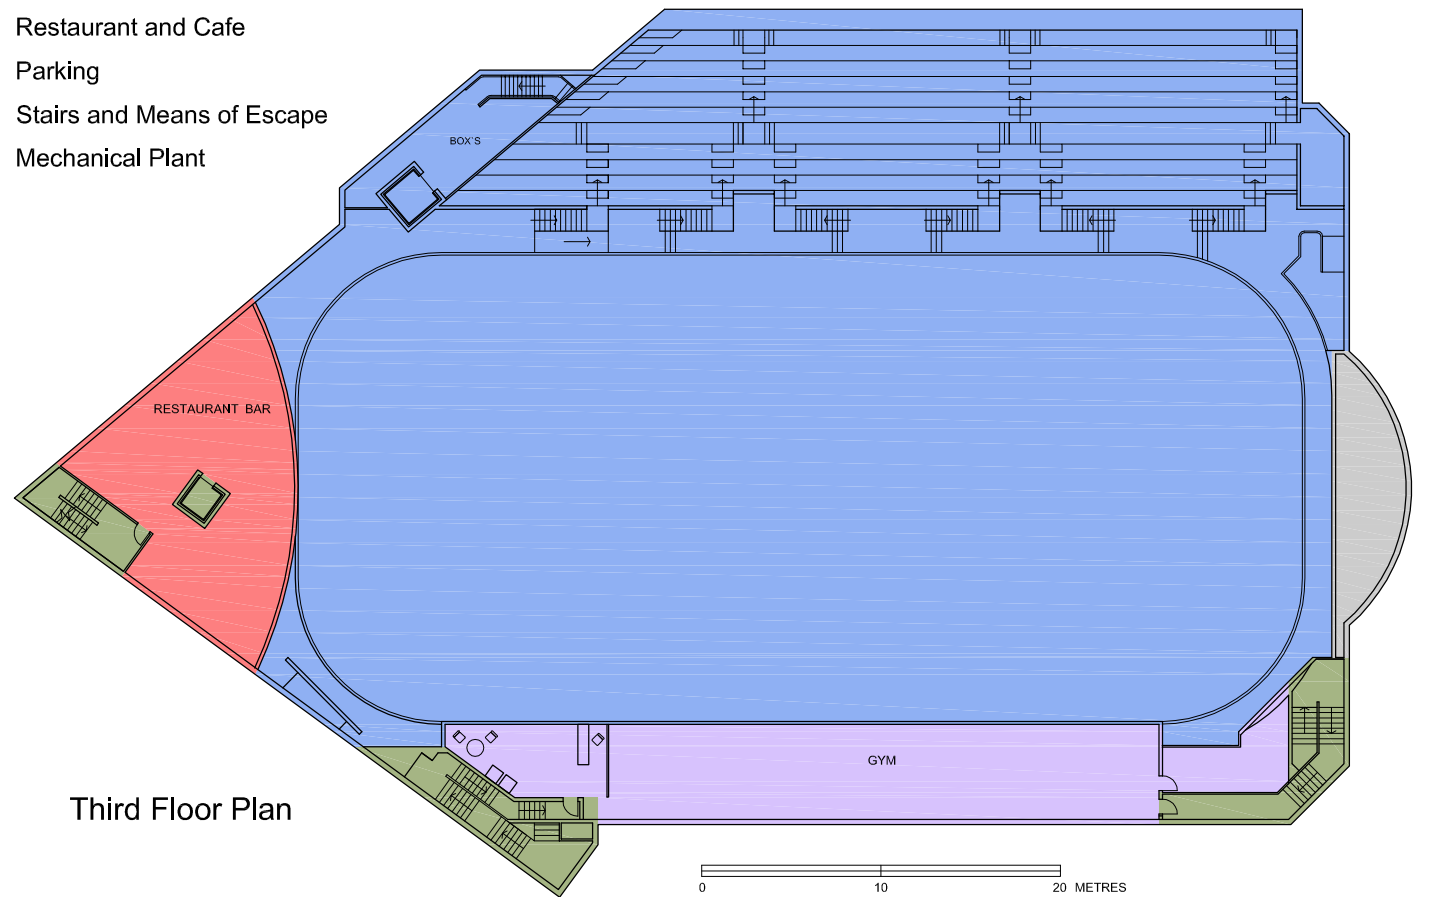

Rev	Amendment	Date	By	Client	Project	Title	Date	Scale
				Warburg Property Developments	St Marys Ice Centre Southampton	Key Plans	13-01-10	N/A
							Job No 102	Dwg No P7
								Rev